

THE
SOCIETY
COMMUNAL LIVE + WORK



Kara Seiler
Capstone Design

Kara Seiler
2510 Butterfield Court
Manhattan, KS, 66502
(913)991-2684
krseiler@ksu.edu

THE SOCIETY
COMMUNAL LIVE + WORK

The Society
302 S 4th St. Manhattan, KS 66502

SOCIETY - COMMUNAL LIVE +
WORK
MANHATTAN, KANSAS

[illegible]

Capstone Project

COVER SHEET

Project number	Capstone
Date	May 2, 2019
Drawn by	Author
Checked by	Checker

G 01

Scale

 
Kara Seiler
2510 Butterfield Court
Manhattan, KS, 66502
(913)991-2684
krseiler@ksu.edu

The Society
302 S 4th St. Manhattan, KS 66502

[illegible]

Project number	Capstone
Date	May 2, 2019
Drawn by	Author
Checked by	Checker

Scale	As indicated
-------	--------------



A1	6 1/8" 2 HOUR PLUMBING PARTITION	A4	2 5/8" PARTITION	A6	1' - 5 1/8" PARTITION
A2	5 1/2" 1 HOUR PARTITION	A5	4 1/4" PARTITION	FEC	FIRE EXTINGUISHER CABINET
A3	3 1/8" 1 HOUR PARTITION	101	DOOR NUMBER		

1. PROVIDE (1) FIRE EXTINGUISHER PER 3000 SQUARE FOOT OF USABLE TENANT SPACE
2. VERIFY ALL STRUCTURAL MECHANICAL AND ELECTRICAL REQUIREMENTS AND COORDINATE REQUIRED CHANGES WITH ARCHITECT PRIOR TO CONSTRUCTION.
3. REFER TO SHEET ID 12.0 FOR DOOR SCHEDULE.



Scale	3/16" = 1'-0"
-------	---------------


Kara Seiler
2510 Butterfield Court
Manhattan, KS, 66502
(913)991-2684
krseiler@ksu.edu

The Society
302 S 4th St. Manhattan, KS 66502

[illegible]

Project number	Capstone
Date	May 2, 2019
Drawn by	Author
Checked by	Checker

Scale	$3/16" = 1'-0"$
-------	-----------------

 

1. FURNITURE AND FIXTURES PROVIDED BY AND INSTALLED BY OWNER'S VENDOR UNLESS OTHERWISE NOTED COORDINATE ALL FURNITURE AND FIXTURE LOCATIONS WITH VENDOR.

2. FURNITURE AND FIXTURES QUANTITIES LISTED ARE FOR REFERENCE ONLY. IT IS OWNER'S RESPONSIBILITY TO VERIFY ALL QUANTITIES AND COORDINATE WITH VENDOR.

Kara Seiler
Capstone Design

Kara Seiler
2510 Butterfield Court
Manhattan, KS, 66502
(913)991-2684
krseiler@ksu.edu

THE
SOCIETY
COMMUNAL LIVE + WORK

The Society
302 S 4th St. Manhattan, KS 66502

SOCIETY - COMMUNAL LIVE +
WORK
MANHATTAN, KANSAS


[illegible]

Capstone Project
ENLARGED PLANS


Project number	Capstone
Date	May 2, 2019
Drawn by	Author
Checked by	Checker

ID 7.0


Scale	As indicated
-------	--------------

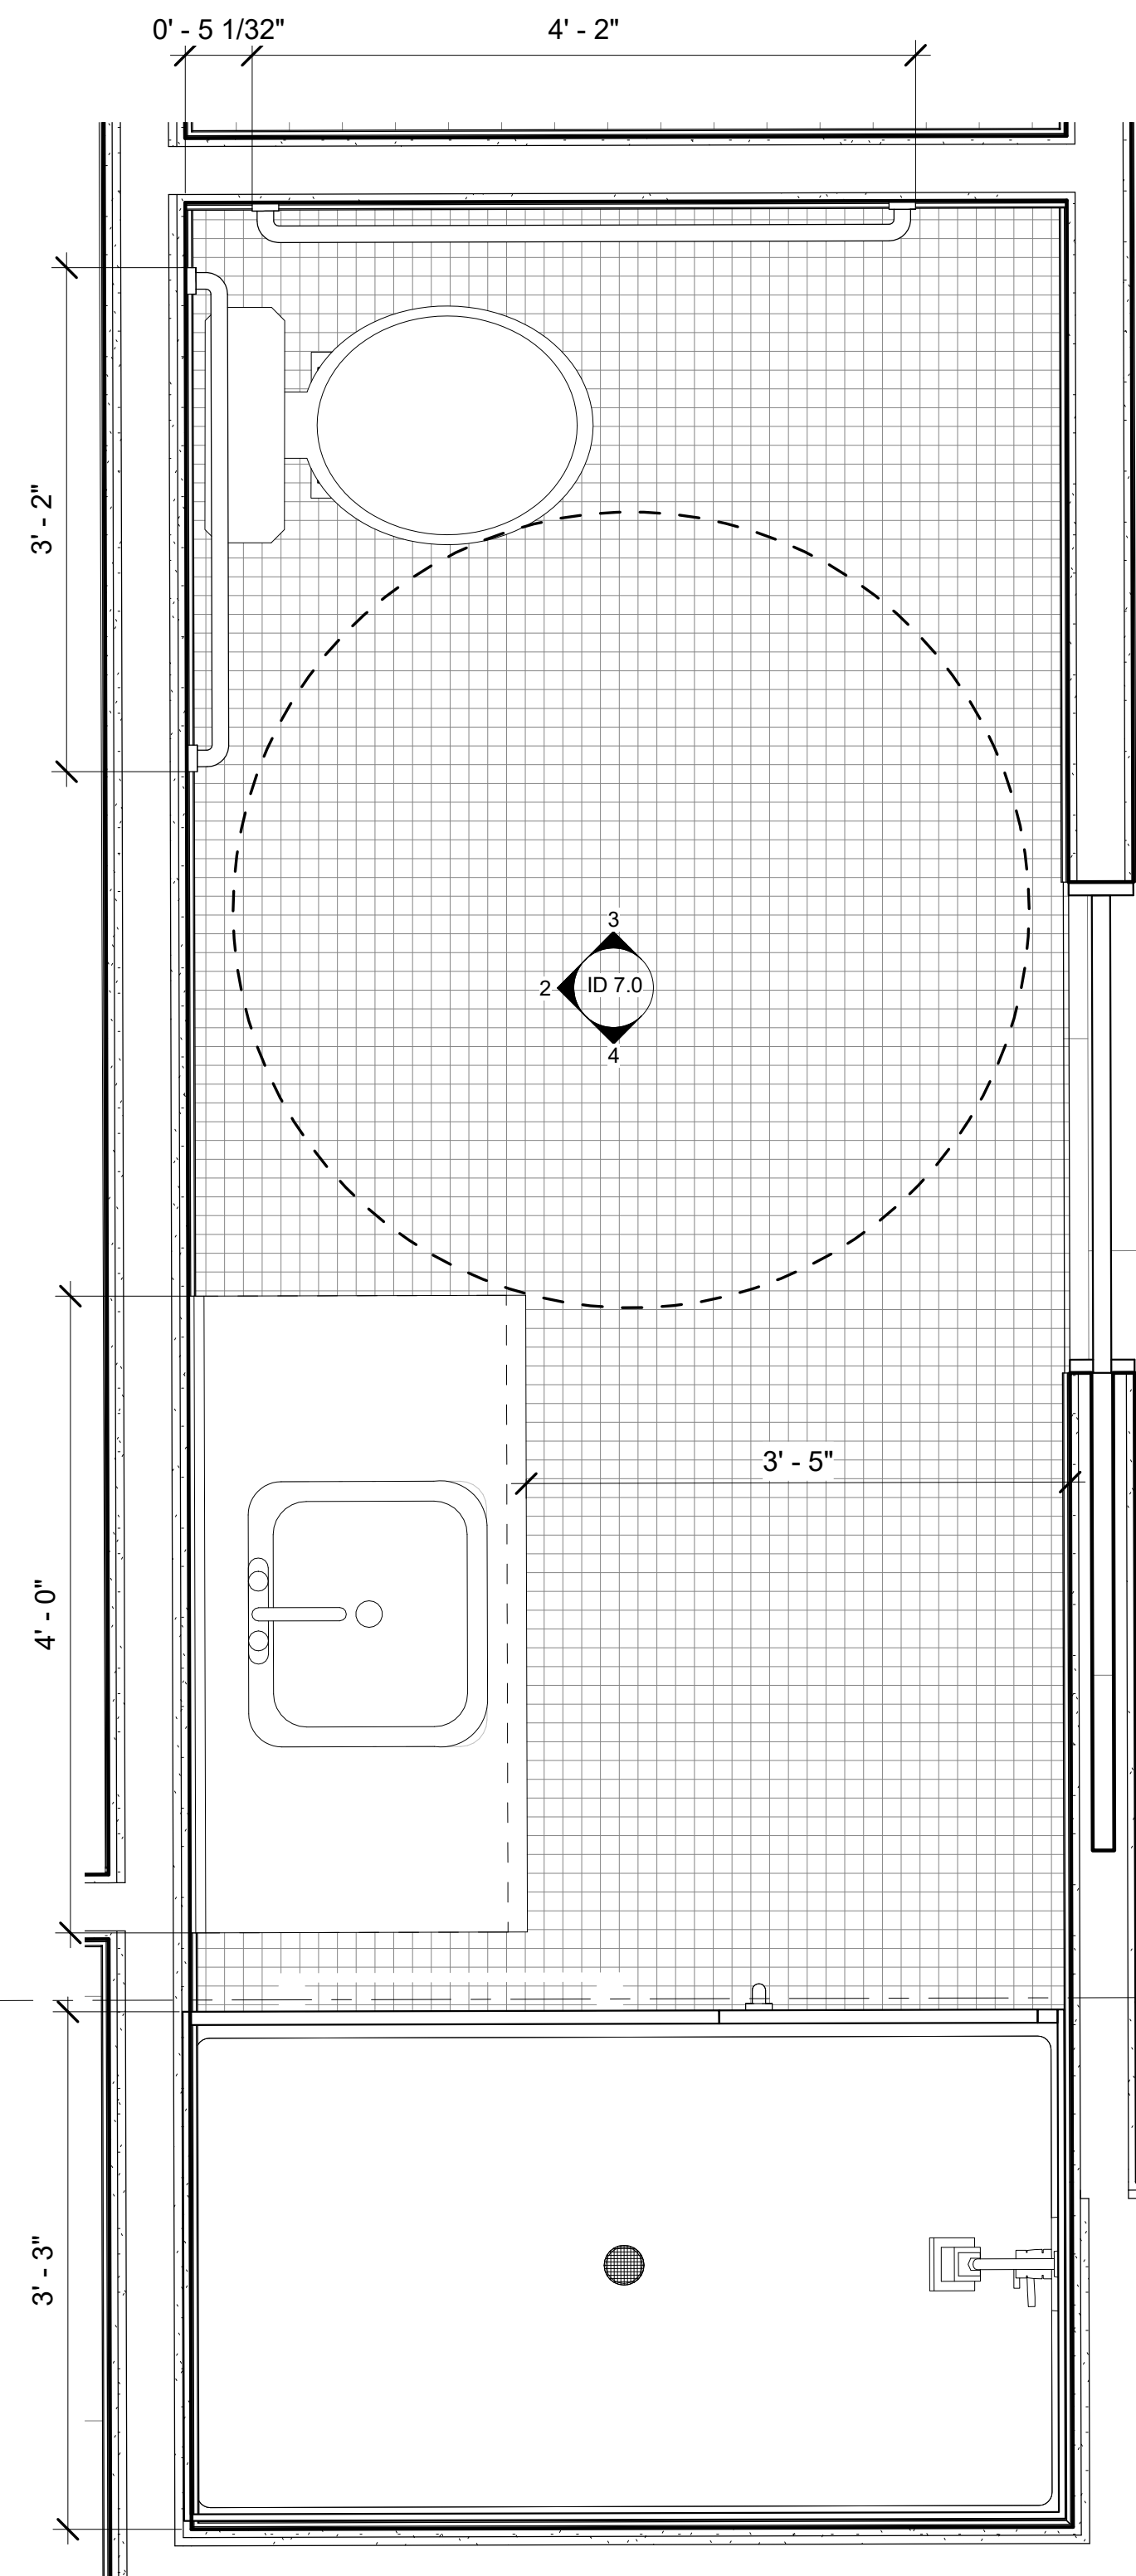


1 ENLARGED BATHROOM PLAN
1" = 1'-0"

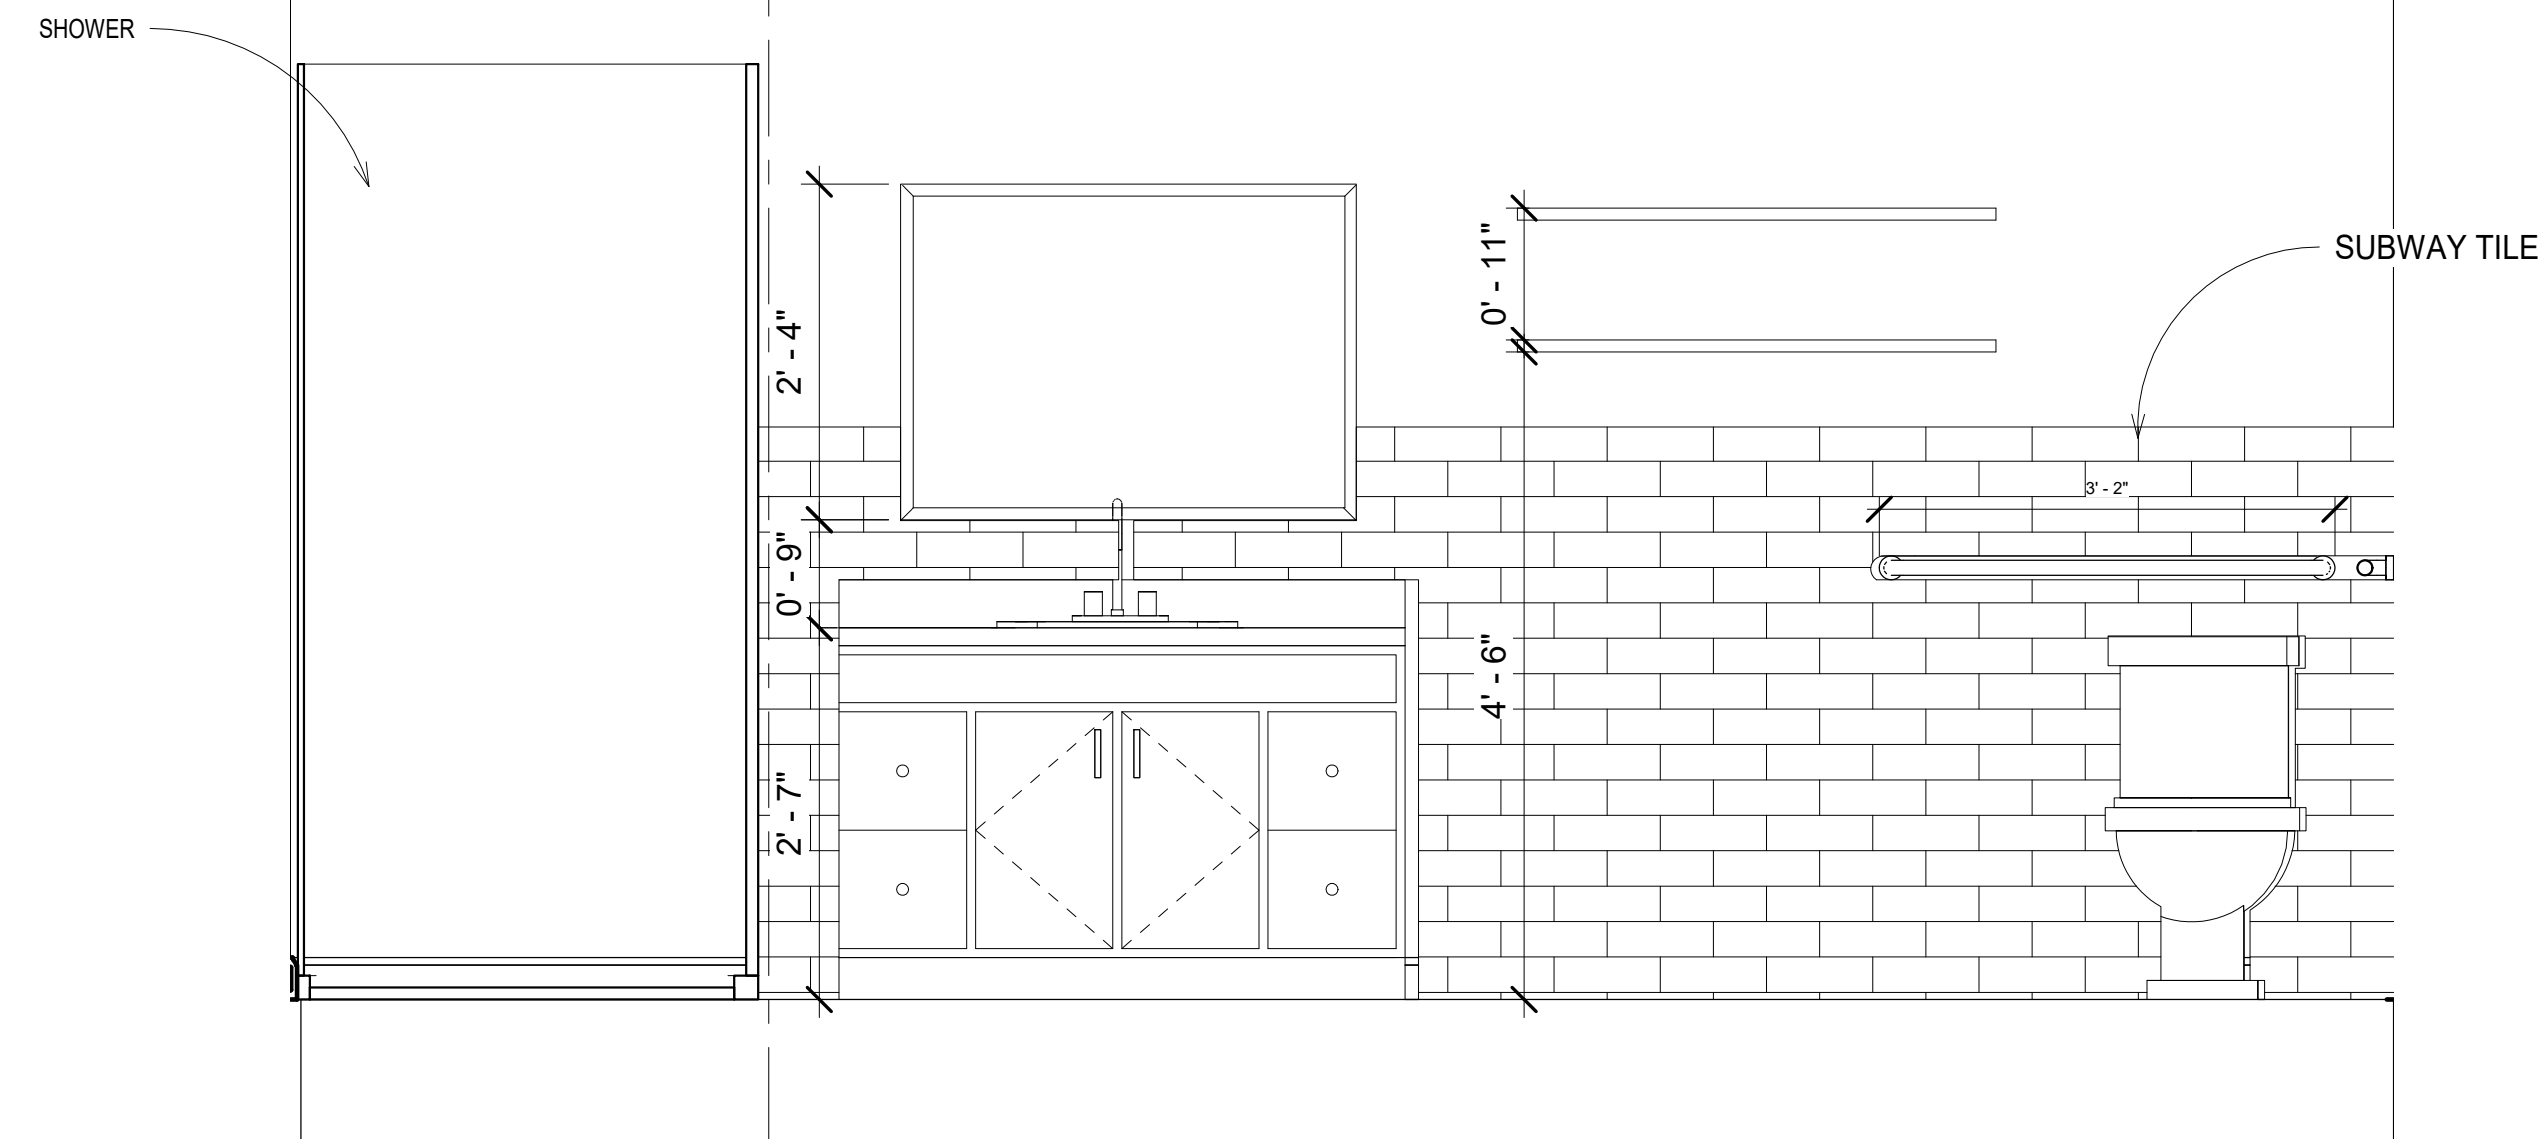

② RESTROOM ELEVATION A
3/4" = 1'-0"

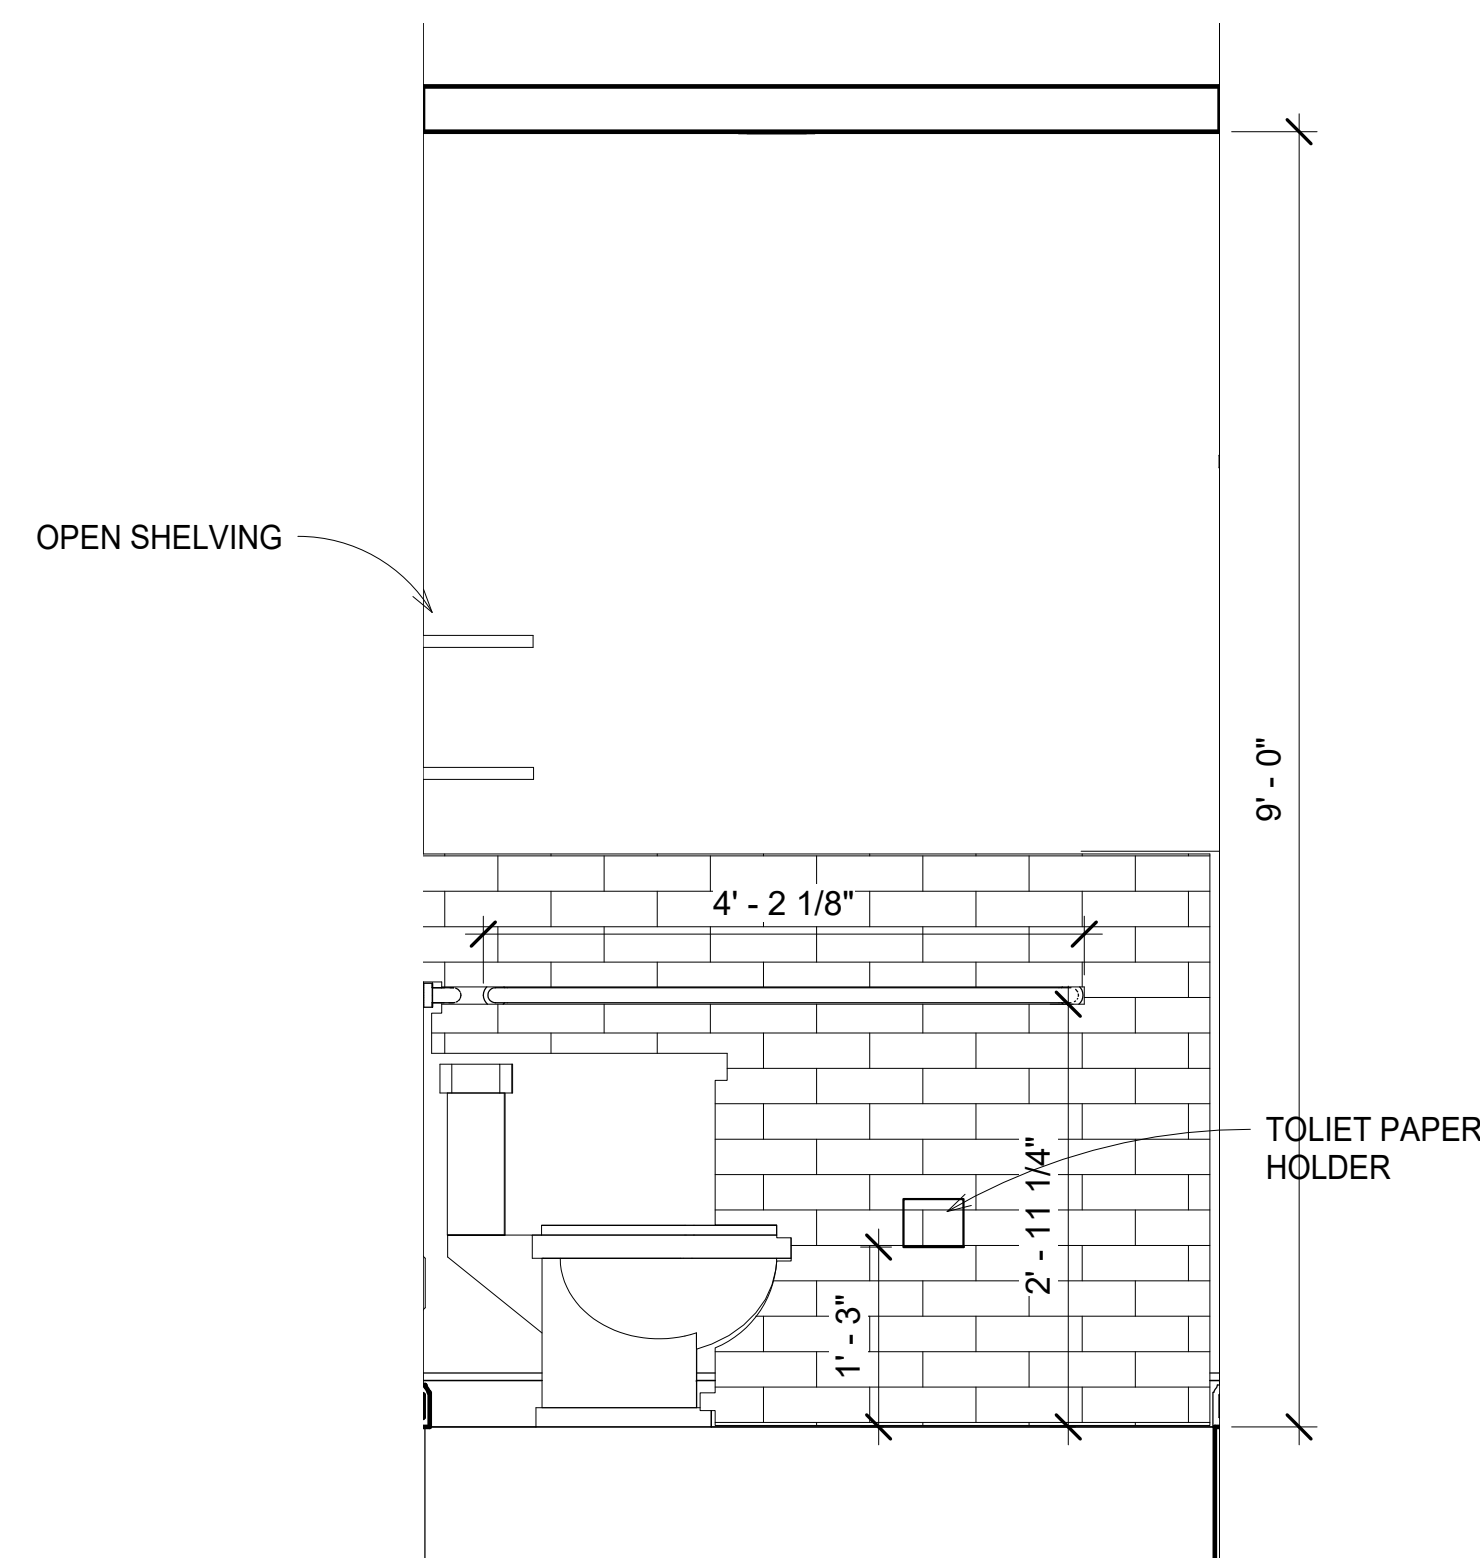

3 RESTROOM ELEVATION B
3/4" = 1'-0"

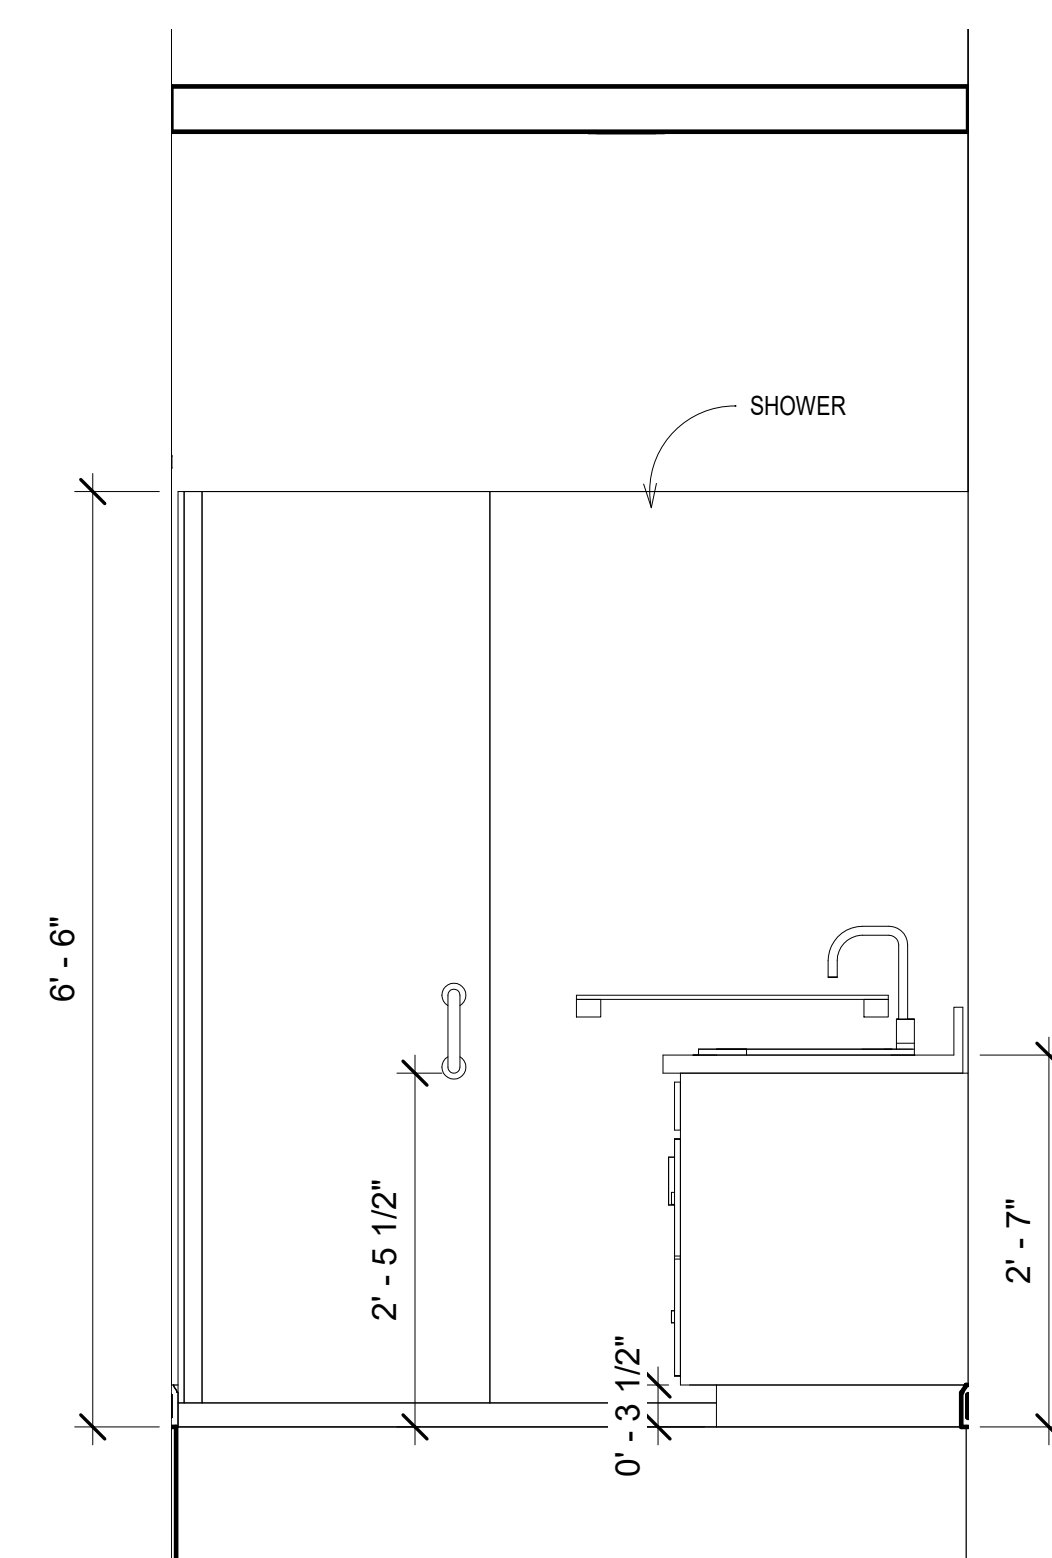

④ RESTROOM ELEVATION C
3/4" = 1'-0"

Kara Seiler
2510 Butterfield Court
Manhattan, KS, 66502
(913)991-2684
krseiler@ksu.edu




The Society
302 S 4th St. Manhattan, KS 66502

SOCIETY - COMMUNAL LIVE +
WORK
MANHATTAN, KANSAS

[illegible]

Project number	Capstone
Date	May 2, 2019
Drawn by	Author
Checked by	Checker

Scale	As indicated
-------	--------------

   

Kara Seiler
2510 Butterfield Court
Manhattan, KS, 66502
(913)991-2684
krseiler@ksu.edu



Technical drawing of a kitchen island showing dimensions and layout. The island is rectangular with a central opening for a sink and a countertop extension on the right side. Dimensions are provided in feet and inches, with some measurements in fractions of an inch.

Dimensions:

- Overall Width:** 7' - 2 5/8"
- Overall Length:** 1' - 10"
- Left Section Width:** 1' - 11 1/2"
- Central Section Width:** 5' - 5 1/2"
- Right Section Width:** 1' - 11 1/2"
- Central Section Depth:** 3' - 8 17/32"
- Right Section Depth:** 1' - 5 5/8" - 4 1/21" - 4 1/2" - 0 7/16"

Labels:

- CEILING FAN

3

4' - 6"

3' - 4"

GFI OUTLET

1' - 0" 1' - 0"

OPEN SHELVING

8' - 11 15/16"

1' - 0"

WOOD COUNTERTOP

23' - 6 5/8"

2' - 3"

3' - 6 1/32"

WASHER

DRYER

Architectural floor plan of a room with dimensions and labels. The plan shows a central area labeled "DIGITAL COMMUNAL CALENDER" with a width of 14' - 0 1/8". To the left is a section labeled "EMERGENCY LIGHT" with a width of 8' - 5 9/16". To the right is a section labeled "SHELVING" with a width of 8' - 6 3/8". The total width of the room is 26' - 0". The depth of the room is 14' - 0 1/8". The plan also shows a "DIGITAL COMMUNAL CALENDER" and an "OUTLET". The dimensions are as follows:

- Left section width: 8' - 5 9/16"
- Central section width: 14' - 0 1/8"
- Right section width: 8' - 6 3/8"
- Top section width: 26' - 0"
- Bottom section width: 26' - 0"
- Left section depth: 1' - 6 1/8"
- Central section depth: 14' - 0 1/8"
- Right section depth: 1' - 6 1/8"
- Bottom section depth: 1' - 6 1/8"

Technical drawing of a kitchen island layout. The island is L-shaped. The top horizontal section is 5' - 9" wide and 2' - 6" high. It features two sets of double doors with dashed diagonal lines, indicating they are swing doors. Below this section, on the left, is a microwave and a mini fridge. The right side of the island is 4' - 6" high and 1' - 6" wide. It features a sink with a faucet and a dishwasher. To the right of the sink and dishwasher are three drawers. The labels 'MICROWAVE' and 'MINI FRIDGE' are placed next to their respective appliances with leader lines. Dimensions are indicated with arrows and text: 5' - 9", 2' - 6", 4' - 6", and 1' - 6".

[illegible]

Project number	Capstone
Date	May 2, 2019
Drawn by	Author
Checked by	Checker

Scale $1/2" = 1'-0"$

Kara Seiler
2510 Butterfield Court
Manhattan, KS, 66502
(913)991-2684
krseiler@ksu.edu



The Society
302 S 4th St. Manhattan, KS 66502

SOCIETY - COMMUNAL LIVE +
WORK
MANHATTAN, KANSAS

[illegible]



Capstone Project

SECTIONS

Project number	Capstone
Date	May 2, 2019
Drawn by	Author
Checked by	Checker

ID 9.0

Scale	3/16" = 1'-0"
-------	---------------

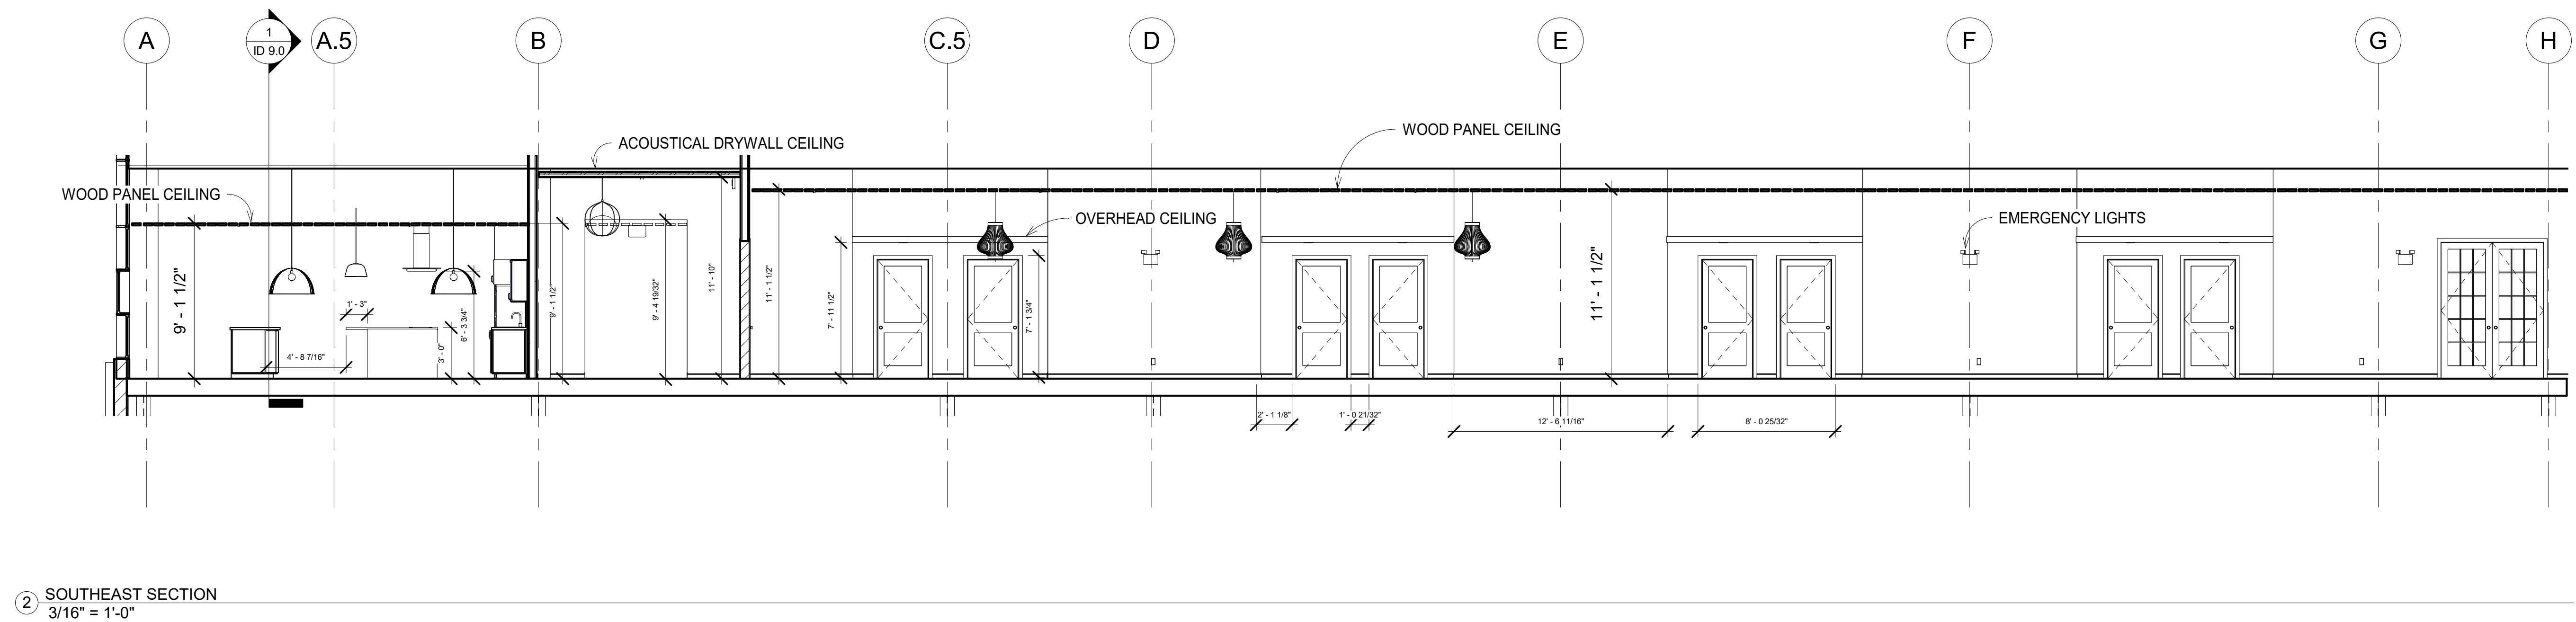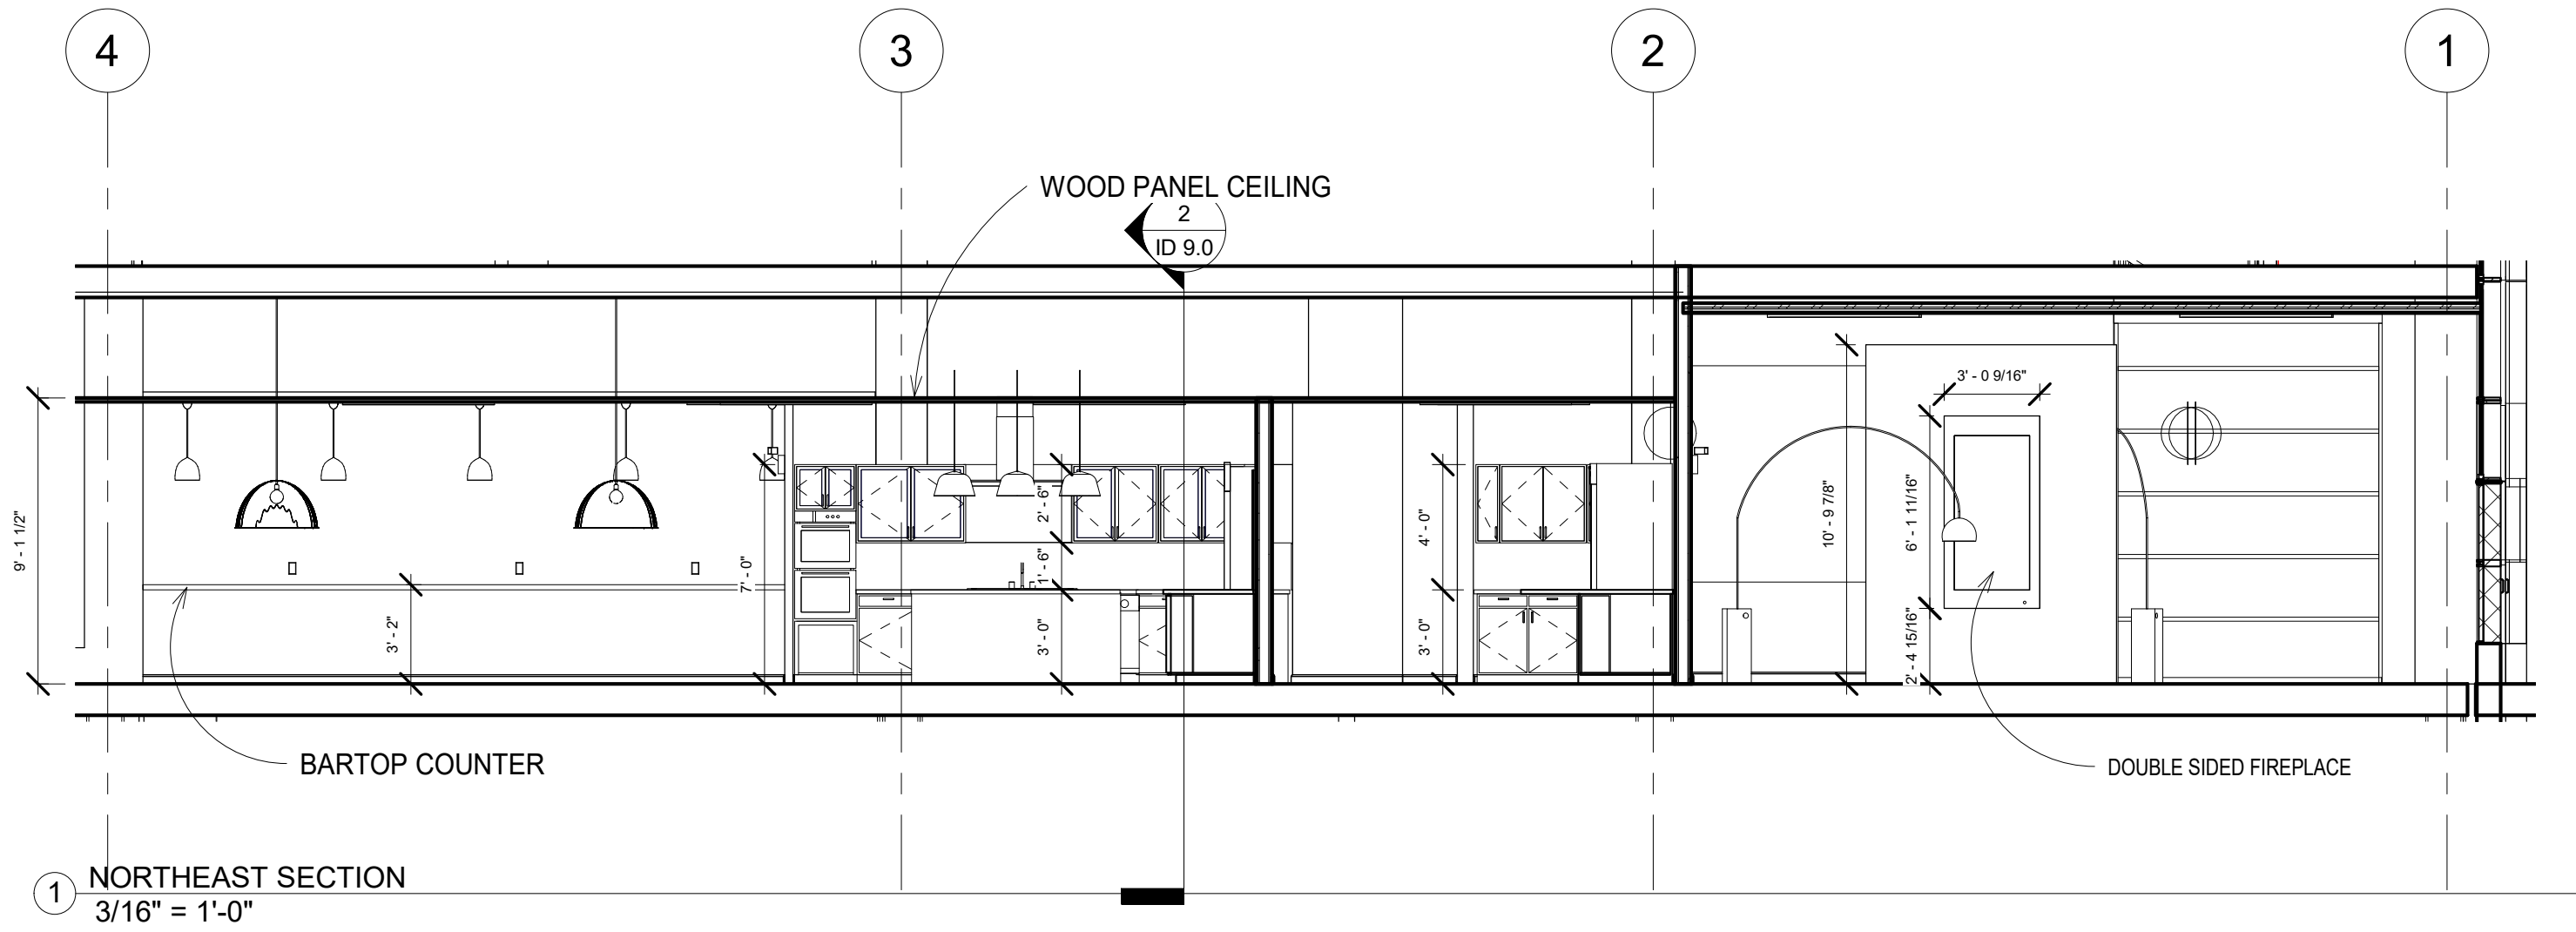

Kara Seiler
2510 Butterfield Court
Manhattan, KS, 66502
(913)991-2684
krseiler@ksu.edu



Diagram illustrating the cross-section of a door assembly with the following dimensions and components:

- Overall width: 0' - 0 3/8"
- Left side dimensions: 0' - 2" (wood door), 0' - 2" (stop), and 0' - 2" (door frame).
- Door frame thickness: 5/8" GWB
- Door frame height: 0' - 4 7/8"
- Door frame material: 2X4 METAL STUD

11' - 10"

9' - 0"

1/2" X 1/4" PLYWOOD BATTEN

BATTEN CLIP

USG 15/16" HEAVY DUTY DX GRID

USG SOLID WOOD GRILLE PANEL

A cross-section diagram of a floor assembly. The top layer is labeled "ARMSTRONG BIRCH ENGINEERED HARDWOOD" and has a wavy wood grain pattern. Below it is a thick, stippled layer labeled "SCHLUTER-RENO-T". To the right of the Schluter-Reno-T is a layer labeled "BOREAL TILE" with a stippled pattern. The bottom layer is a thick, stippled concrete slab. A vertical black line represents a wall or partition, showing the Schluter-Reno-T layer extending up to the hardwood and the Boreal Tile layer extending to the right.

[illegible]





Side elevation drawing of a kitchen island. The island features a quartz countertop and a glass door. The overall height is 3' - 0". The countertop is 2' - 6" high. The glass door is 2' - 1" high. The sink is 1' - 6" high. The island has a total width of 3' - 0". The countertop is labeled "QUARTZ COUNTERTOP". The glass door is labeled "GLASS DOOR". The sink is labeled "SINK". The island has a total width of 3' - 0". The countertop is 2' - 6" high. The glass door is 2' - 1" high. The sink is 1' - 6" high.

[illegible][illegible]

Project number	Capstone
Date	May 2, 2019
Drawn by	Author
Checked by	Checker


Scale	As indicated
-------	--------------

   LIGHTING FIXTURE SCHEDULE






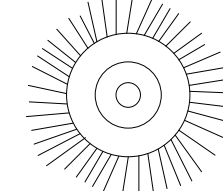
LIGHTING FIXTURE SCHEDULE							
FIXTURE NUMBER	MANUFACTUROR	QUANTITY	LAMP TYPE	VOLTAGE	MOUNTING	DESCRIPTION	IMAGE
DN140B LED10S/830 PSD-E WR	PHILIPS LIGHTING	104	LED	220-240 V	RECESSED CAN	6" DOWNLIGHT	
LL523X	PHILIPS LIGHTING	33	LED	220-240 V	SUSPENDED	TRUNKING SYSTEM	
UNDER THE BELL LAMP	MUUTO	8	LED	120 V	SUSPENDED	PENDANT LIGHT	
AMBIT PENDANT LAMP	MUUTO	8	LED	120 V	SUSPENDED	PENDANT LIGHT	
8425301	GLOBAL LIGHTING	3	LED		SUSPENDED	PENDANT LIGHT	
MEDIUM ORIENT LIGHT	HIGHTOWER	4	LED		SUSPENDED	PENDANT LIGHT	
MONO LIGHT	BUZZI SPACE	3	LED	220-240 V	SUSPENDED	PENDANT LIGHT	

DOOR SCHEDULE


DOOR SCHEDULE							
TYPE	COUNT	OPERATION	WIDTH	HEIGHT	THICKNESS	MATERIAL/ FINISH	FIRE CODE
DOOR TYPE 'A'	13	SINGLE SWING	3' - 0"	7' - 0"	1- 3/8"	WALNUT	20 MIN
DOOR TYPE 'B'	12	SINGLE POCKET	3' - 0"	6' - 8"	1- 3/8"	WALNUT	20 MIN
DOOR TYPE 'C'	12	BI-FOLD	3' - 6"	7' - 0"	1- 3/4"	WALNUT	20 MIN
DOOR TYPE 'D'	2	DOUBLE SWING	6' - 0"	8' - 0"	1- 3/8"	WALNUT	20 MIN
DOOR TYPE 'E'	2	SINGLE SWING	4' - 0"	8' - 0"	1- 3/8"	WALNUT	20 MIN
DOOR TYPE 'F'	4	DOUBLE SWING	6' - 6 1/2"	6' - 3"	1- 3/4"	METAL	20 MIN

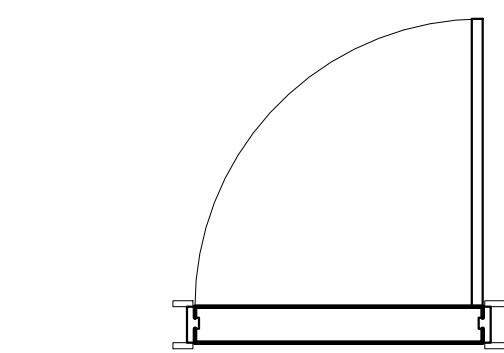


DOOR LEGEND
1/2" = 1'-0"

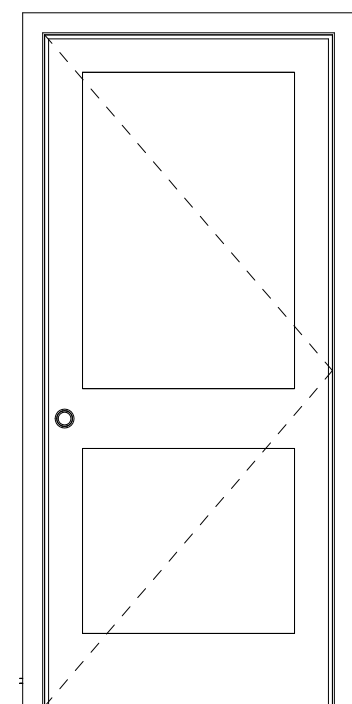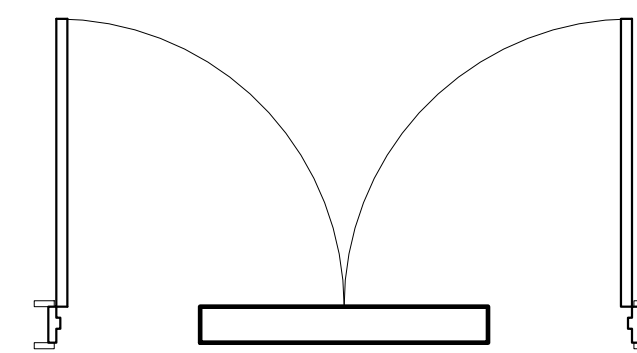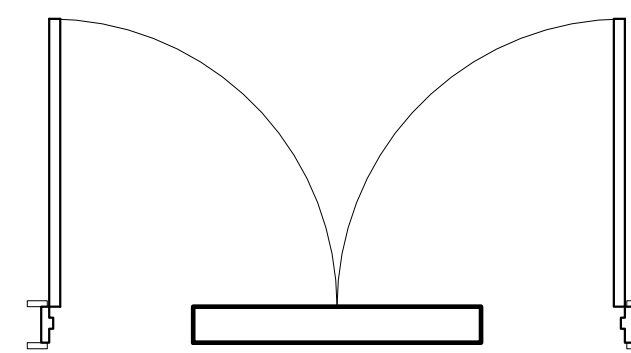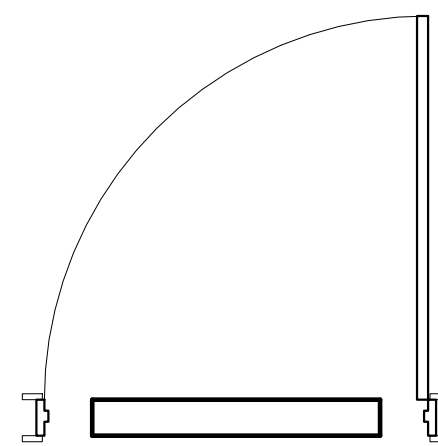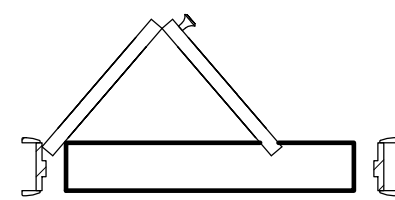 


① DOOR TYPE 'A'
1/2" = 1'-0"

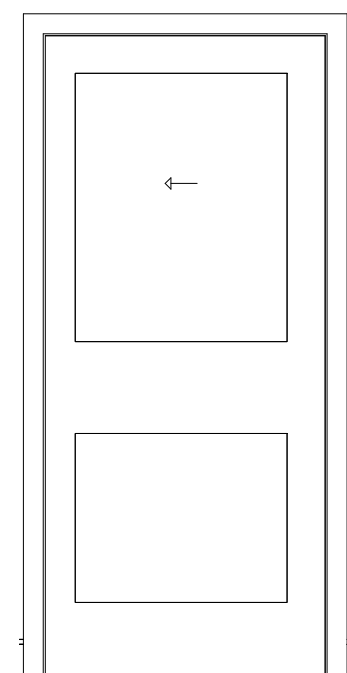


② DOOR TYPE 'B'
1/2" = 1'-0"

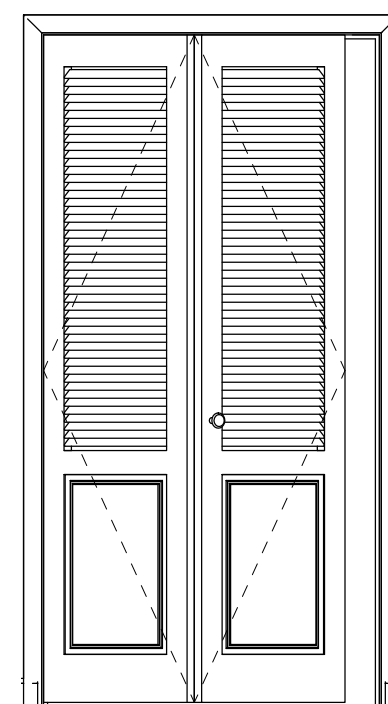


③ DOOR TYPE 'C'
1/2" = 1'-0"

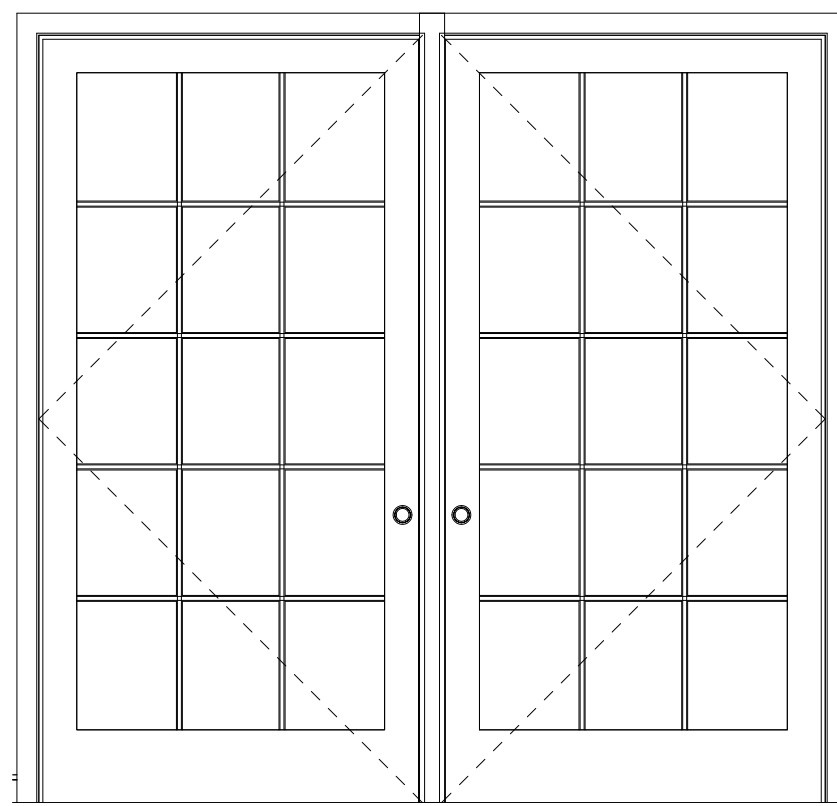

4 DOOR TYPE 'D'
1/2" = 1'-0"

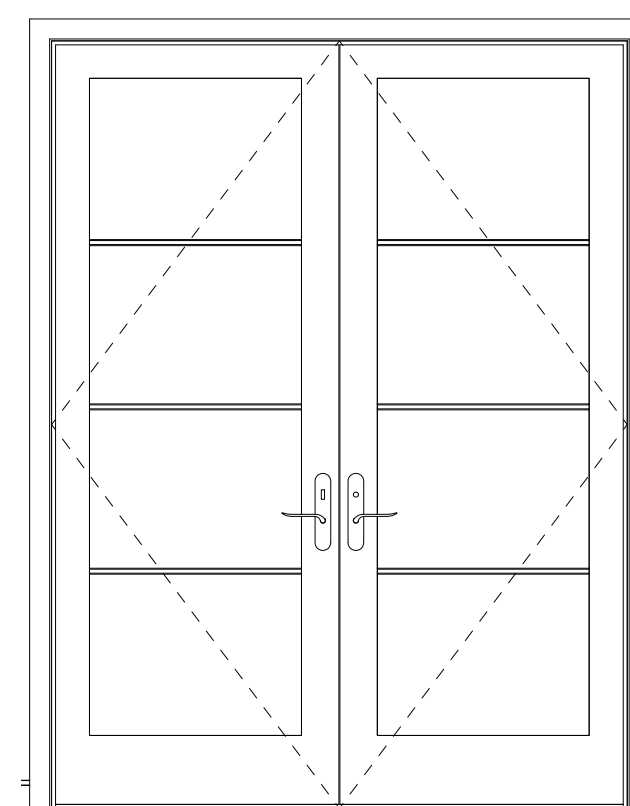

5 DOOR TYPE 'E'
1/2" = 1'-0"

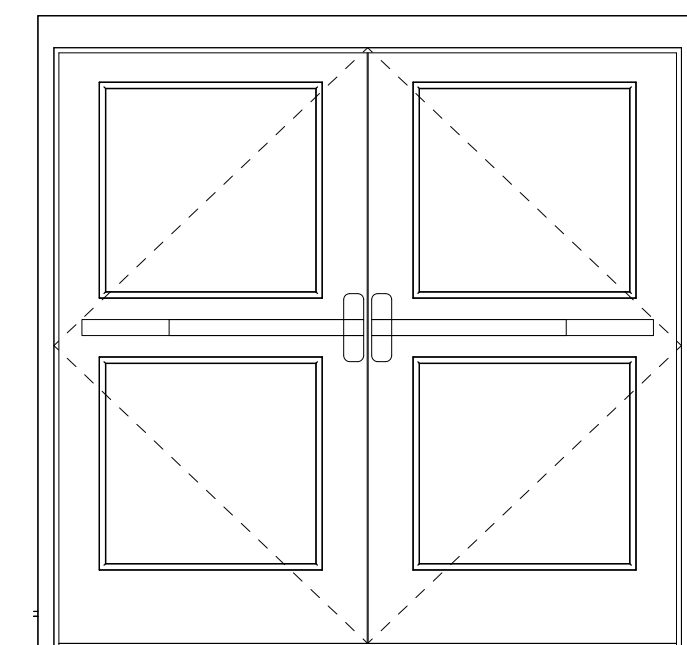

6 DOOR TYPE 'F'
1/2" = 1'-0"

Kara Seiler
Capstone Design

Kara Seiler
2510 Butterfield Court
Manhattan, KS, 66502
(913)991-2684
krseiler@ksu.edu

THE SOCIETY
COMMUNAL LIVE + WORK

The Society
302 S 4th St. Manhattan, KS 66502

SOCIETY - COMMUNAL LIVE +
WORK
MANHATTAN, KANSAS

[illegible]

Capstone Project

SCHEDULES

Project number	Capstone
Date	May 2, 2019
Drawn by	Author
Checked by	Checker
ID 11.0	
Scale	1/2" = 1'-0"